


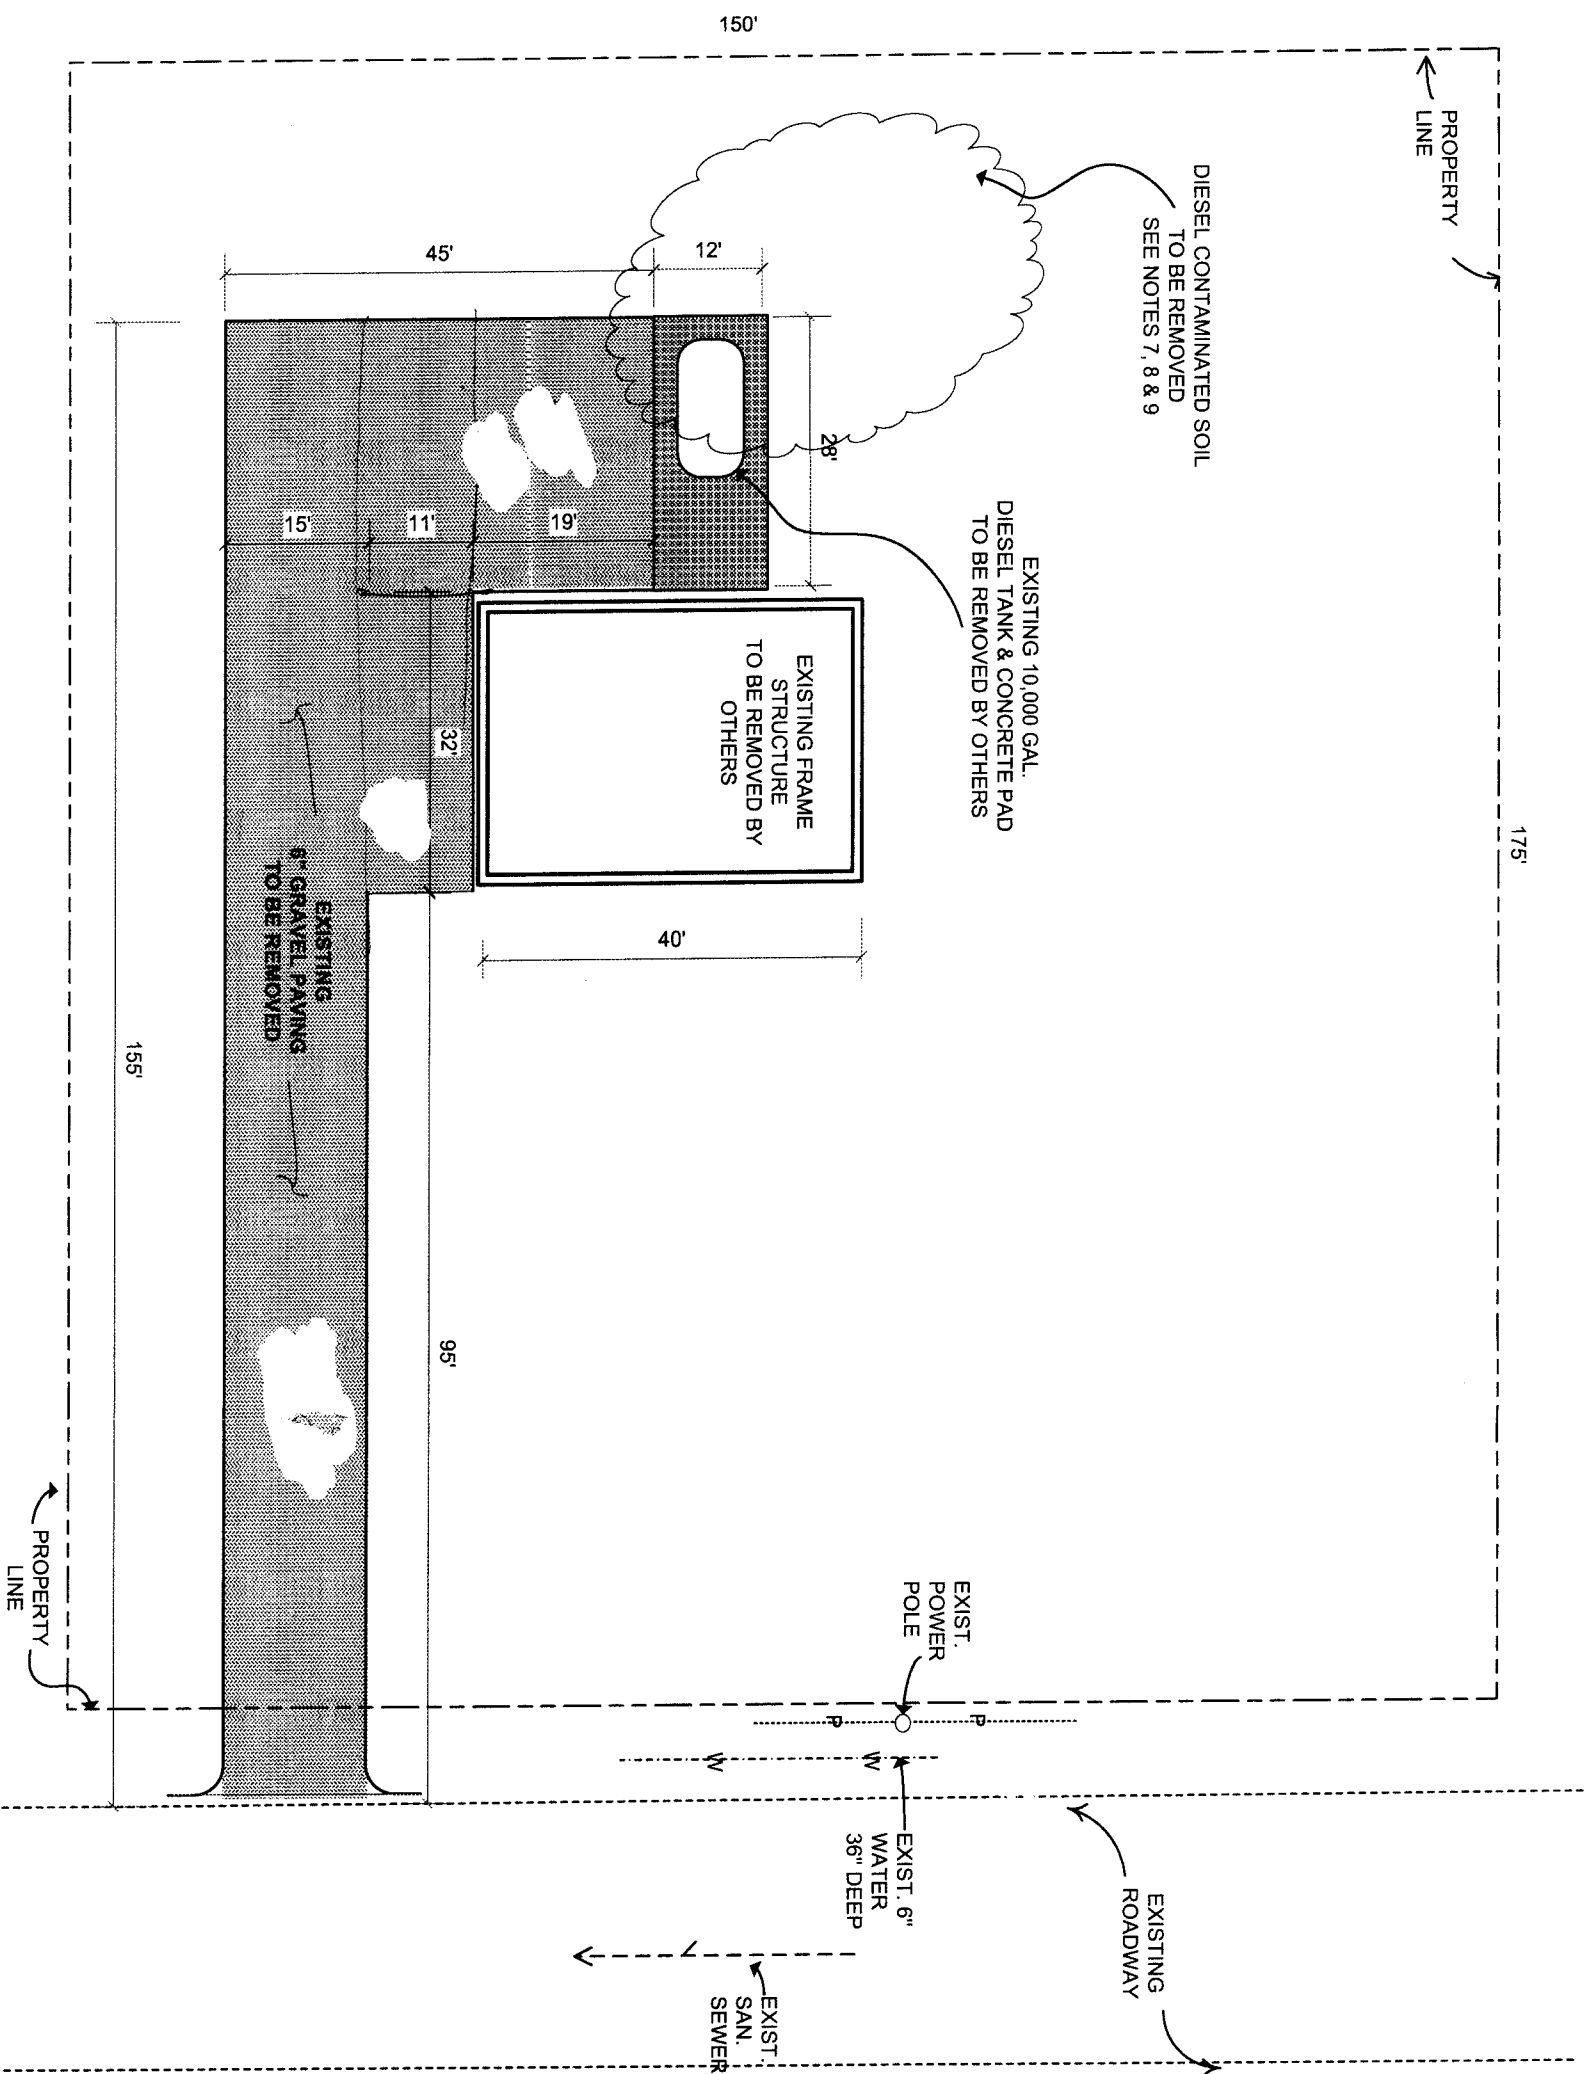


NOTES:





1. LIGHT CLEARING & GRUBBING ON UNDEVELOPED PORTION OF SITE.
2. SITE GRADING INCLUDING BLDG PAD IS BALANCED. AVG CUT/FILL = 1.0'
3. SOIL TYPE IS MEDIUM AND NO ROCK ANTICIPATED.
4. REMOVE EXISTING 6" GRAVEL PAVING AND TRANSPORT TO STOCKPILE LOCATION (1 MILE HAUL)
5. EXISTING FRAME STRUCTURE TO BE REMOVED BY OTHERS
6. EXISTING DIESEL FUEL TANK AND CONCRETE PAD TO BE REMOVED BY OTHERS
7. DIESEL CONTAMINATED SOIL PLUME HAS BEEN CHARACTERIZED TO BE APPROX. 34' X 46' X 6' DEEP
8. NO GROUNDWATER CONTAMINATION DETECTED
9. EXCAVATE TO 1' OUTSIDE AND BELOW CONTAMINATION LEVEL, HAUL TO DESIGNATED DISPOSAL SITE (8 MILE HAUL) AND BACKFILL WITH CLEAN SOIL

Scale: 1" = 20'		Drawn By: G. P. Burdell
Date: January 2010		
STORAGE FACILITY		
SITE DEVELOPMENT PLAN		Drawing Number: C-1

- NOTES:**
1. USE REINFORCED CONCRETE PIPE, CLASS III, FOR STORM DRAINAGE PIPING.
 2. USE TYPE K COPPER RISING FOR WATER LINES.
 3. USE VITRIFIED CLAY PIPE FOR SANITARY SEWER PIPING.


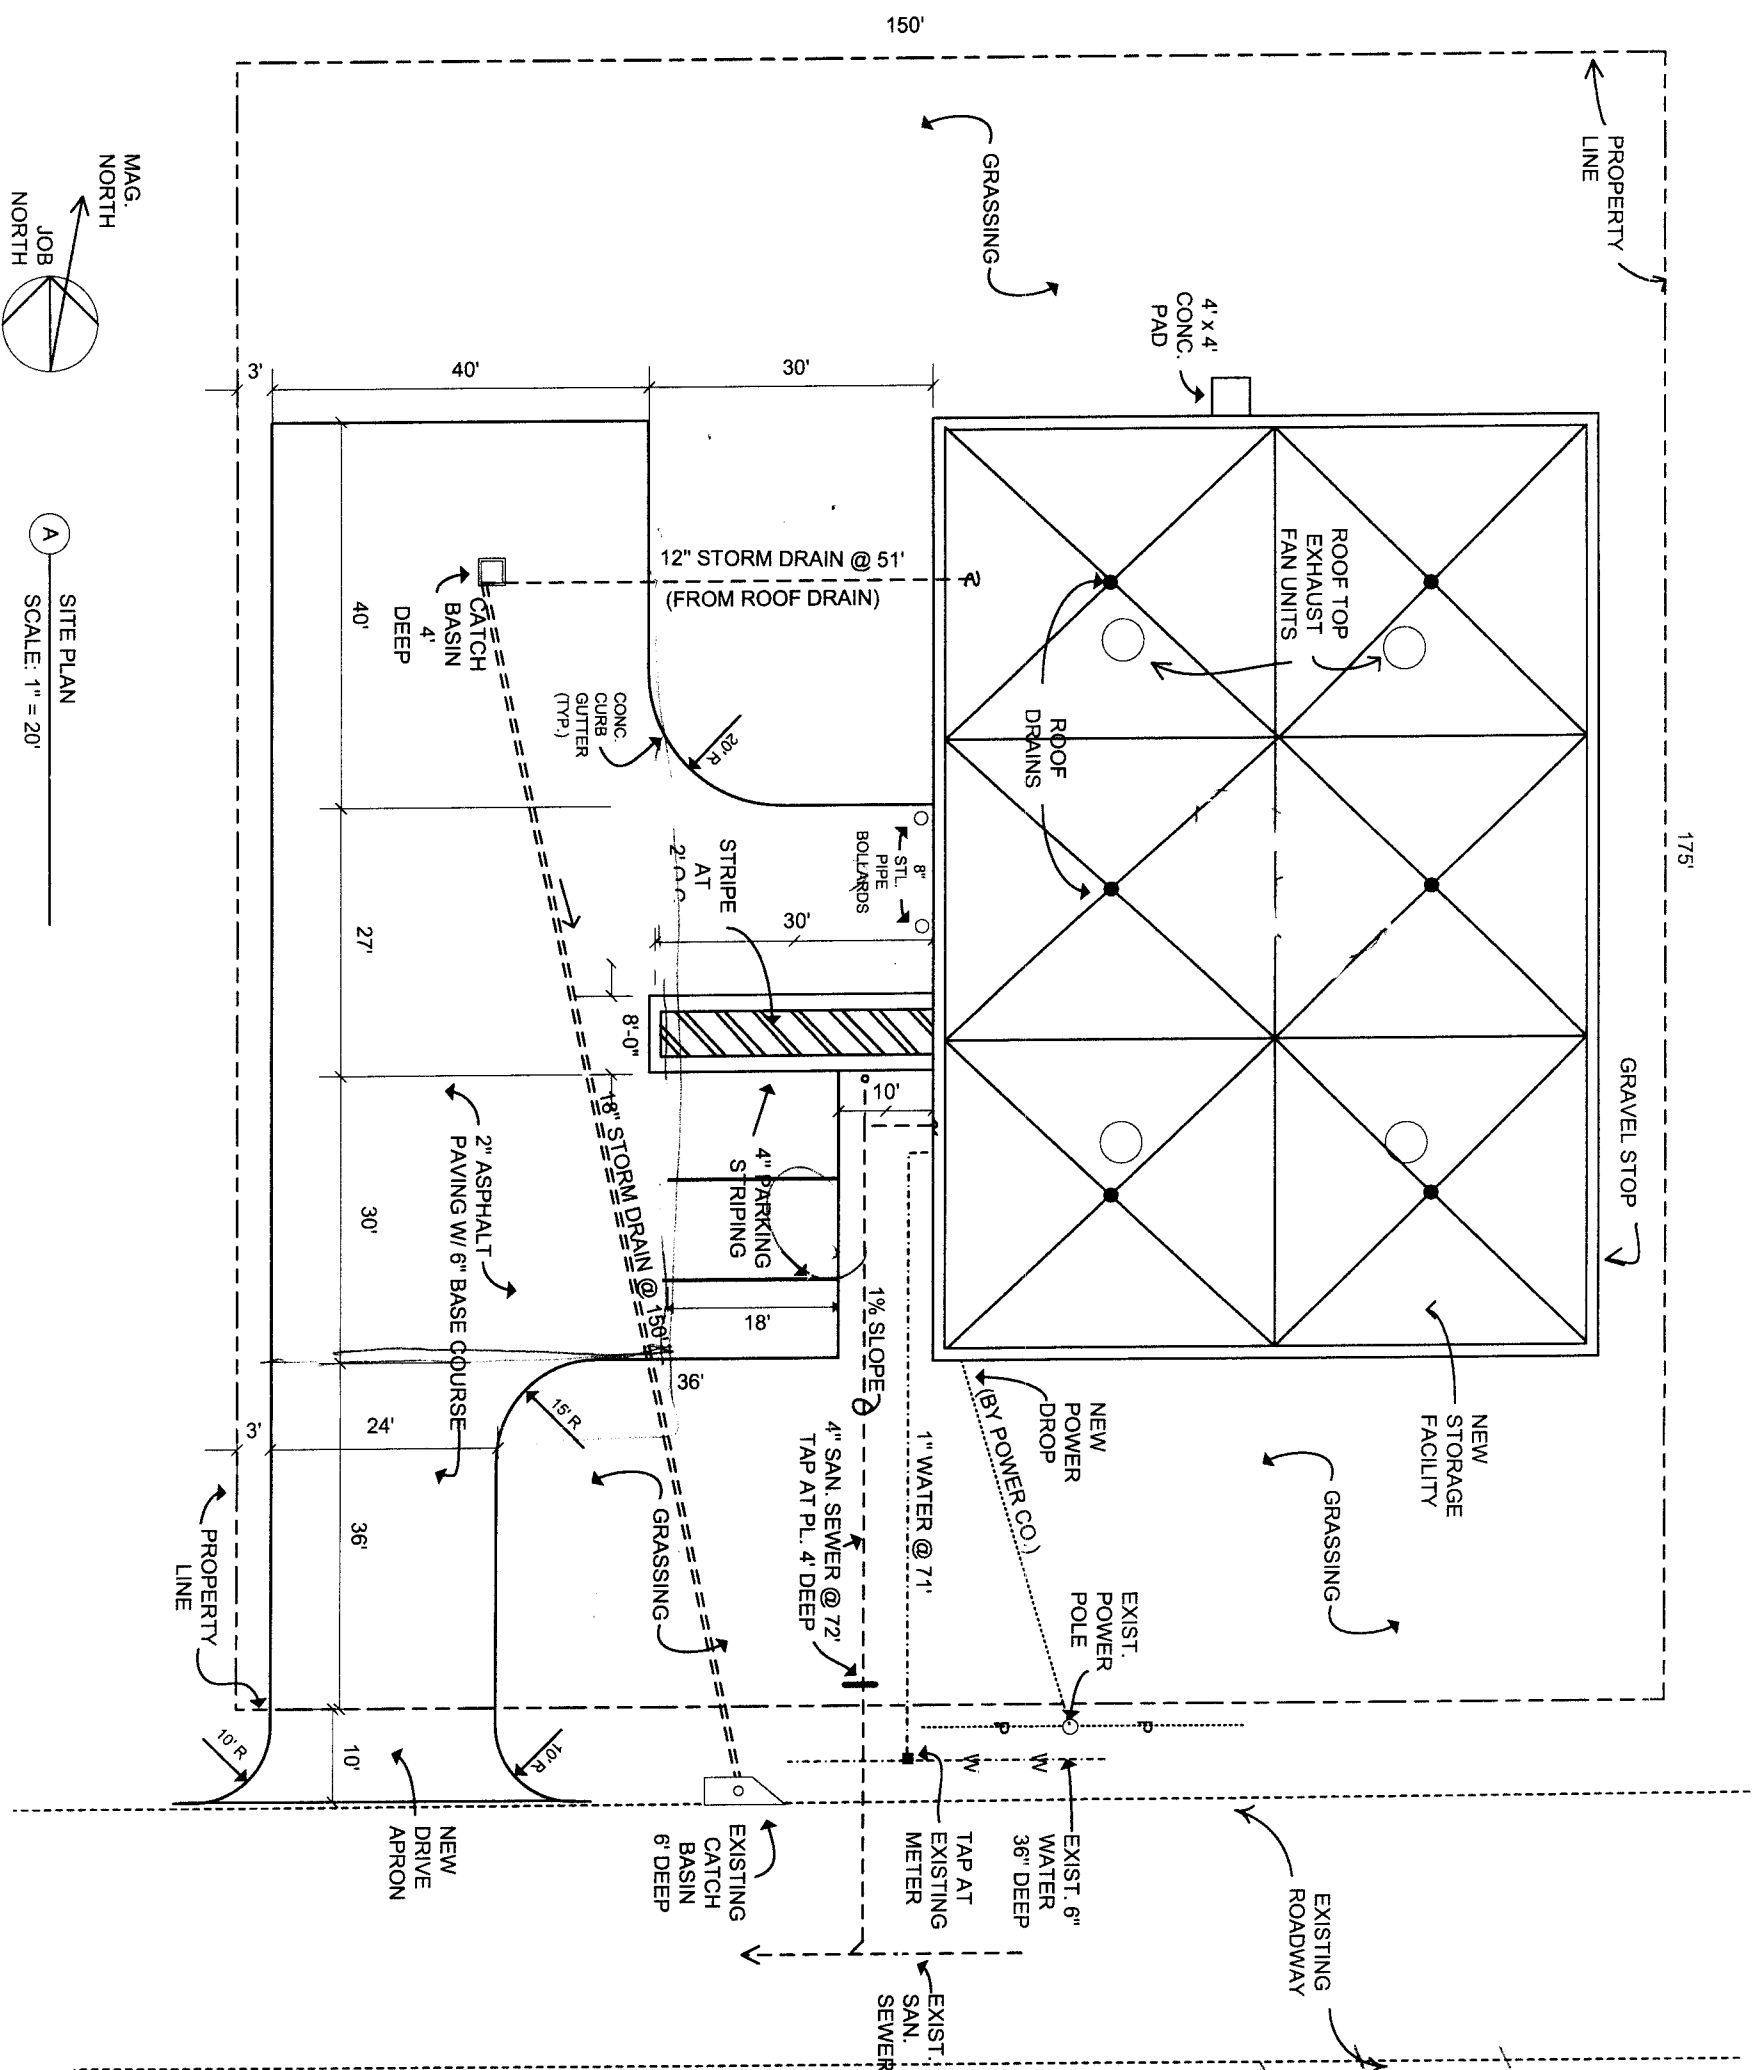


Scale:	1" = 20'	Drawn By: G. P. Burdell	
Date:	January 2010		
STORAGE FACILITY			
SITE IMPROVEMENT PLAN		Drawing Number: C-2	

 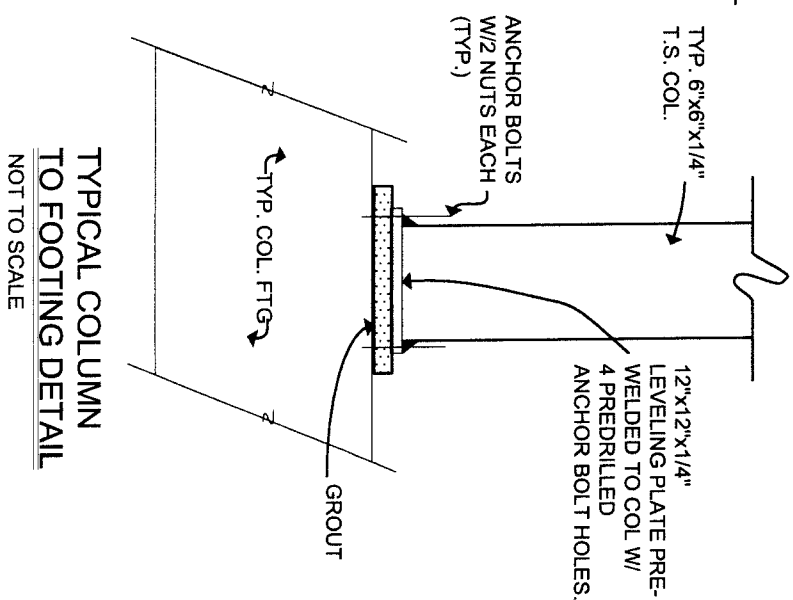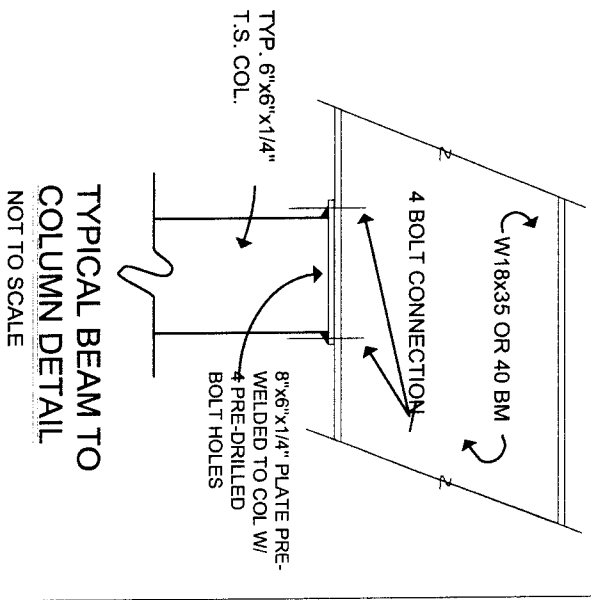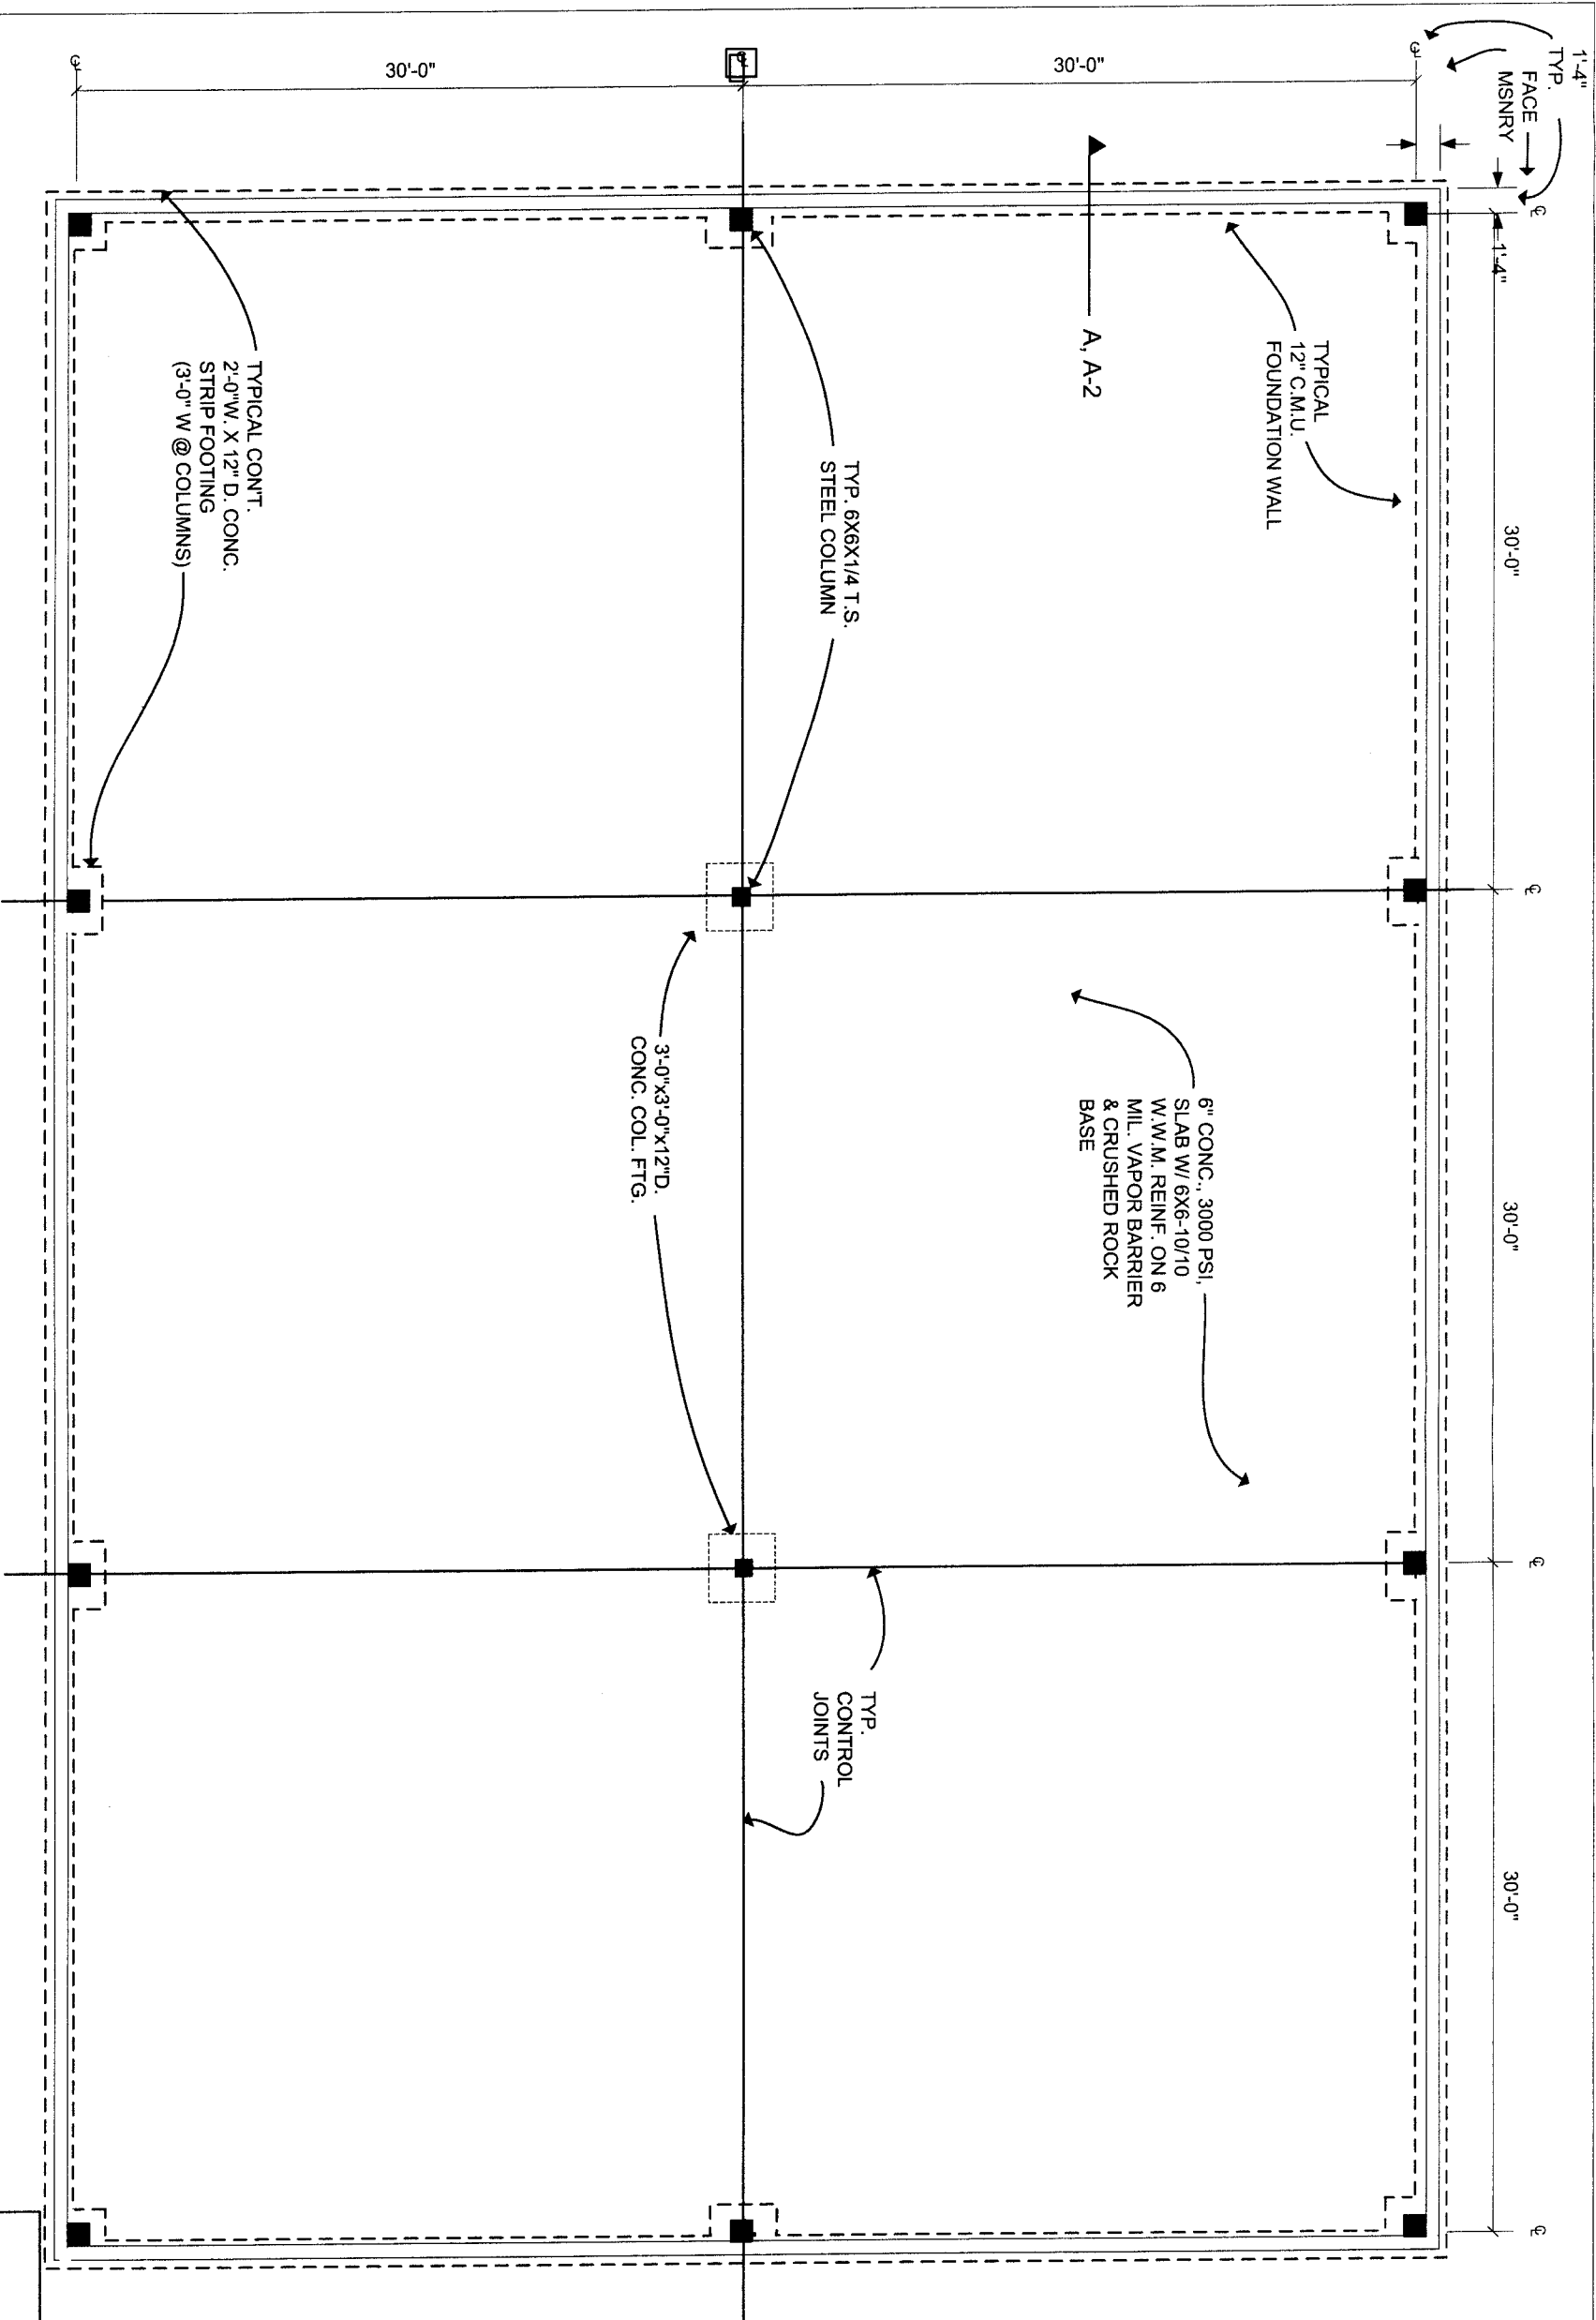

SLAB & FOUNDATION PLAN
SCALE: 1/8" = 1'-0"

Scale: 1/8" = 1'		Drawn By:
Date: January 2010		G. P. Burdell
STORAGE FACILITY		Drawing Number:
FOUNDATION PLAN		S-1

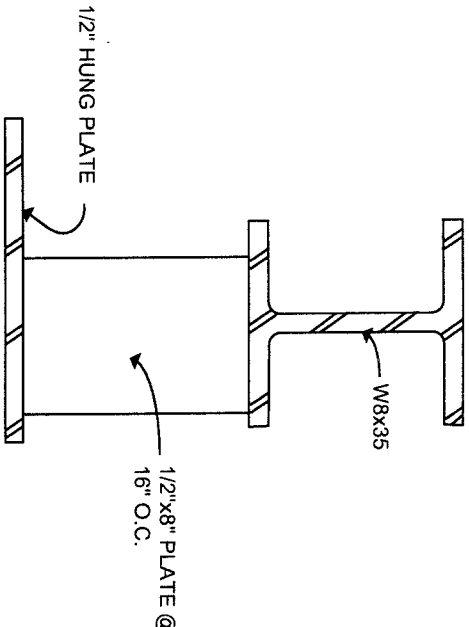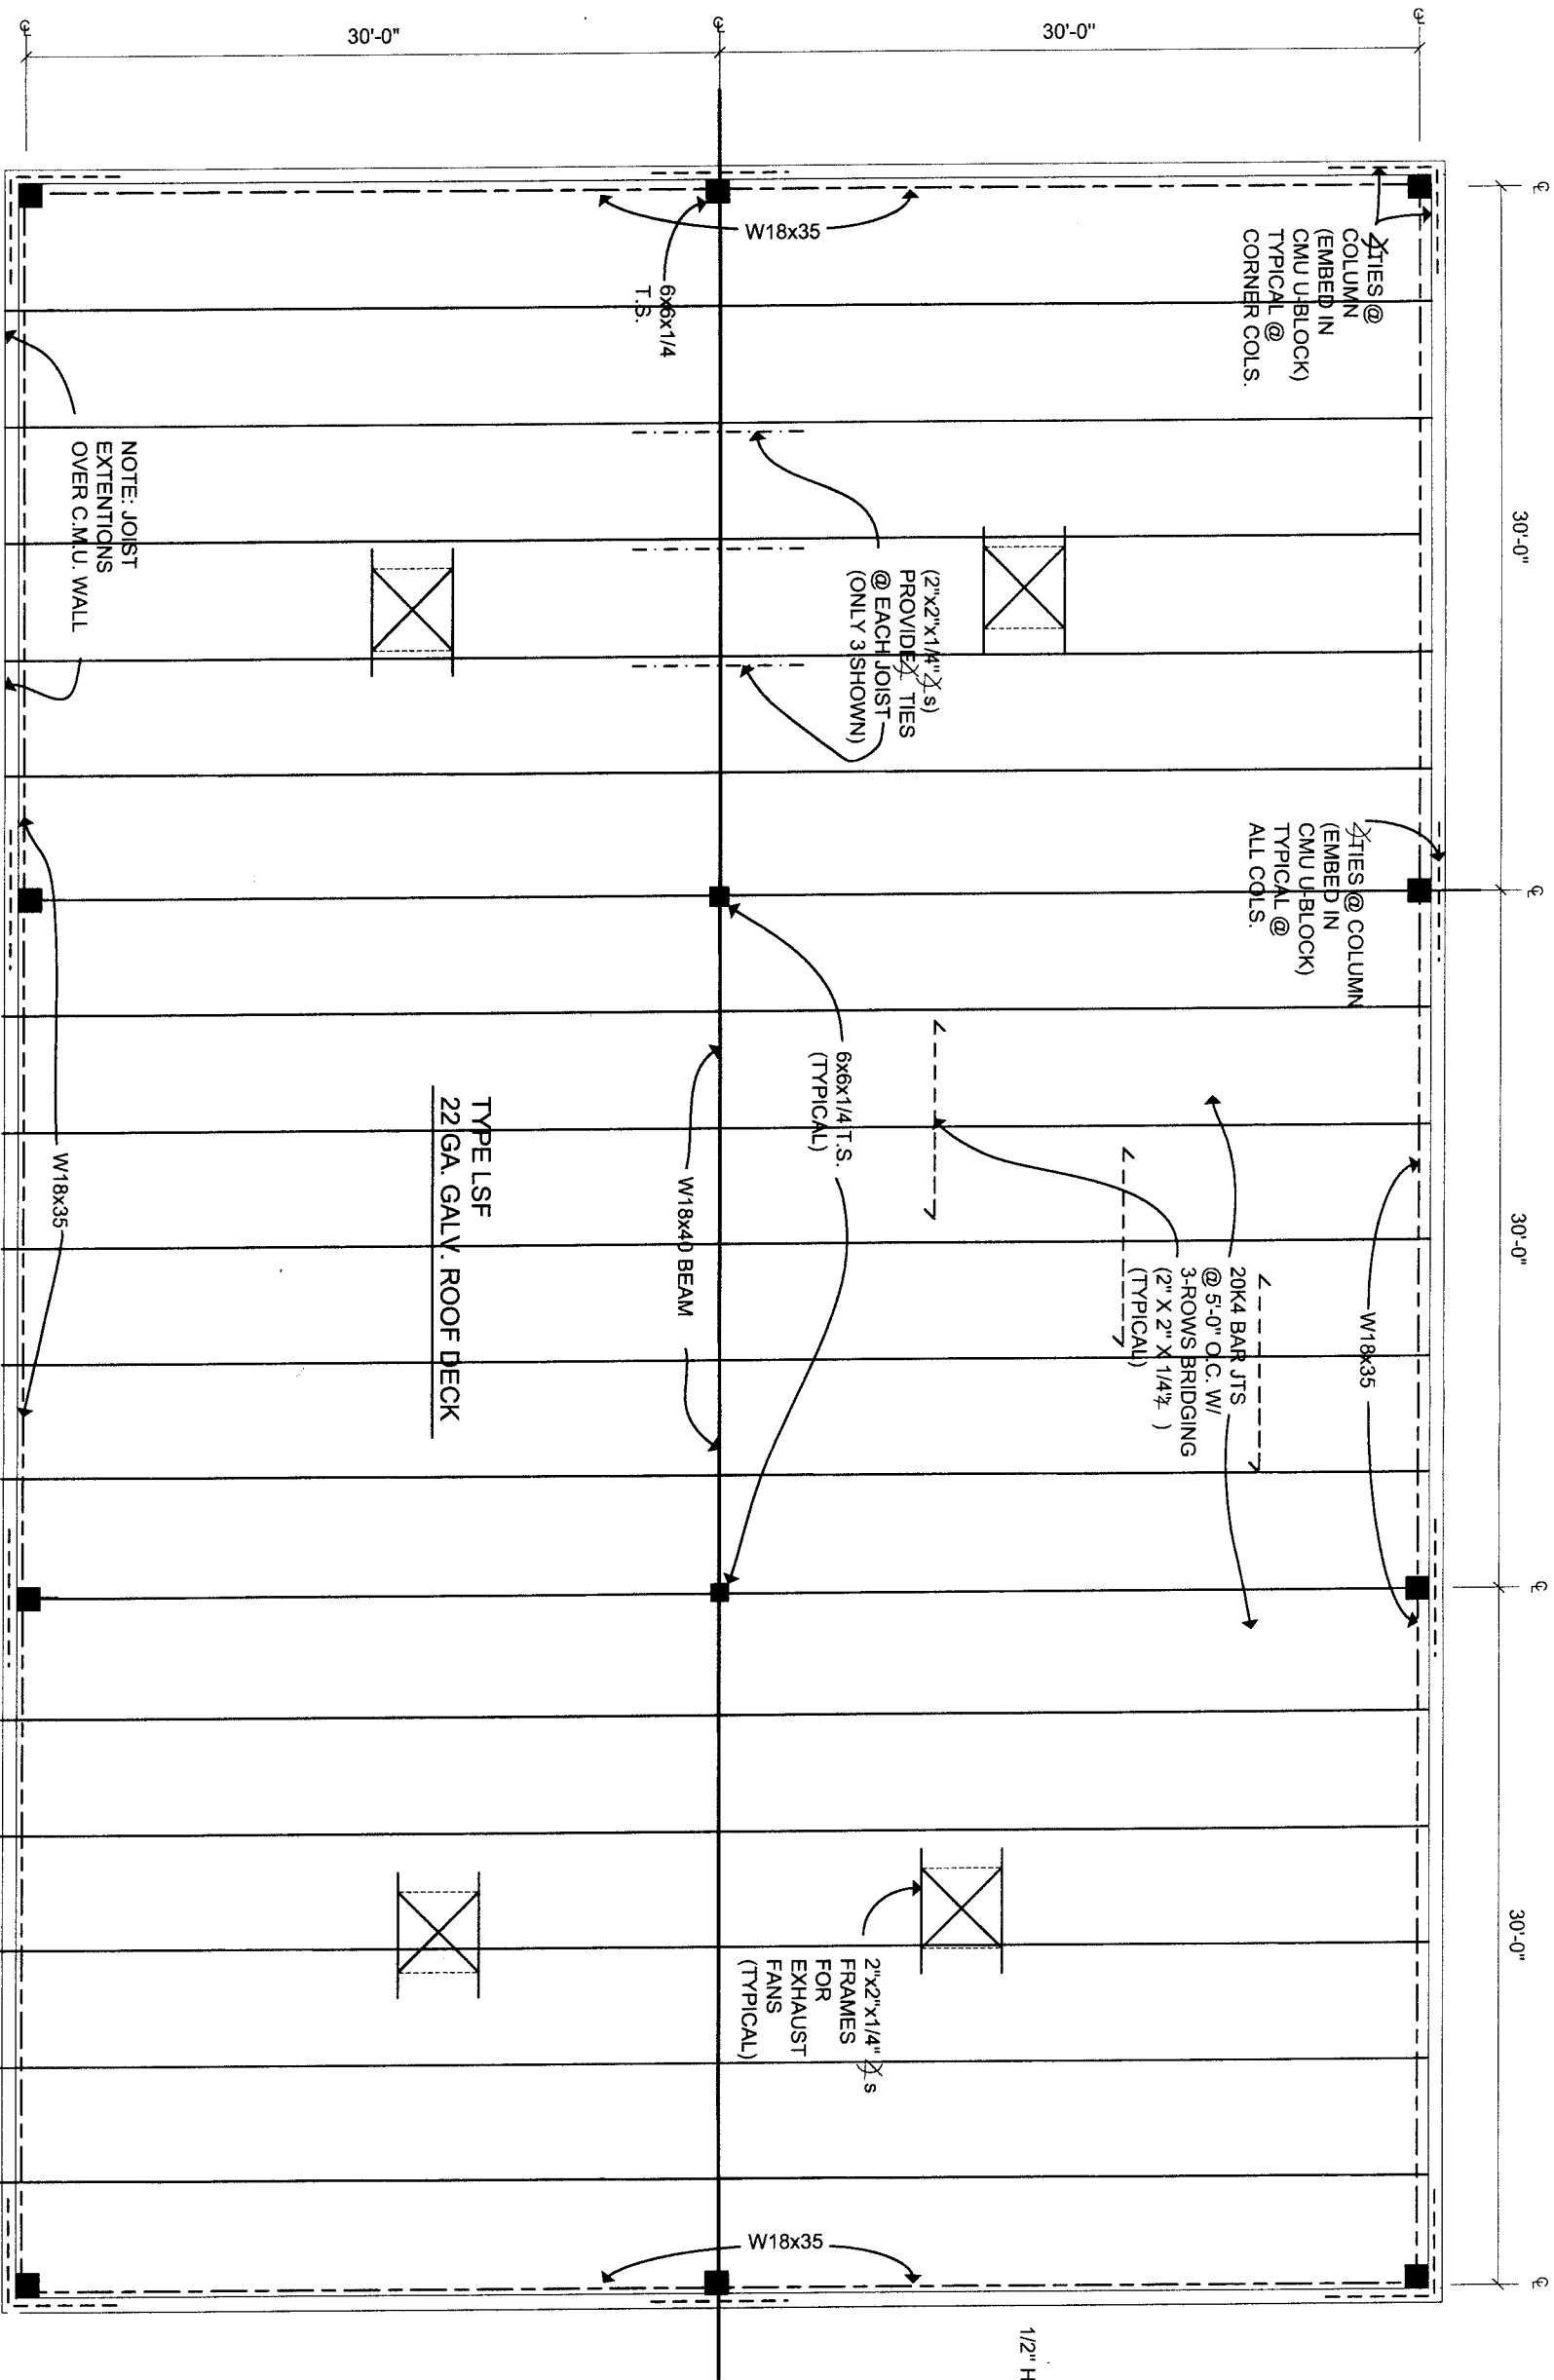


OVERHEAD DOOR
LINTEL DETAIL
NOT TO SCALE




ROOF FRAMING PLAN
SCALE: 1/8" = 1'-0"

Scale: 1/8" = 1'		Drawn By:	
Date: January 2010		G. P. Burdell	
STORAGE FACILITY		Drawing Number:	
ROOF FRAMING PLAN		S-2	

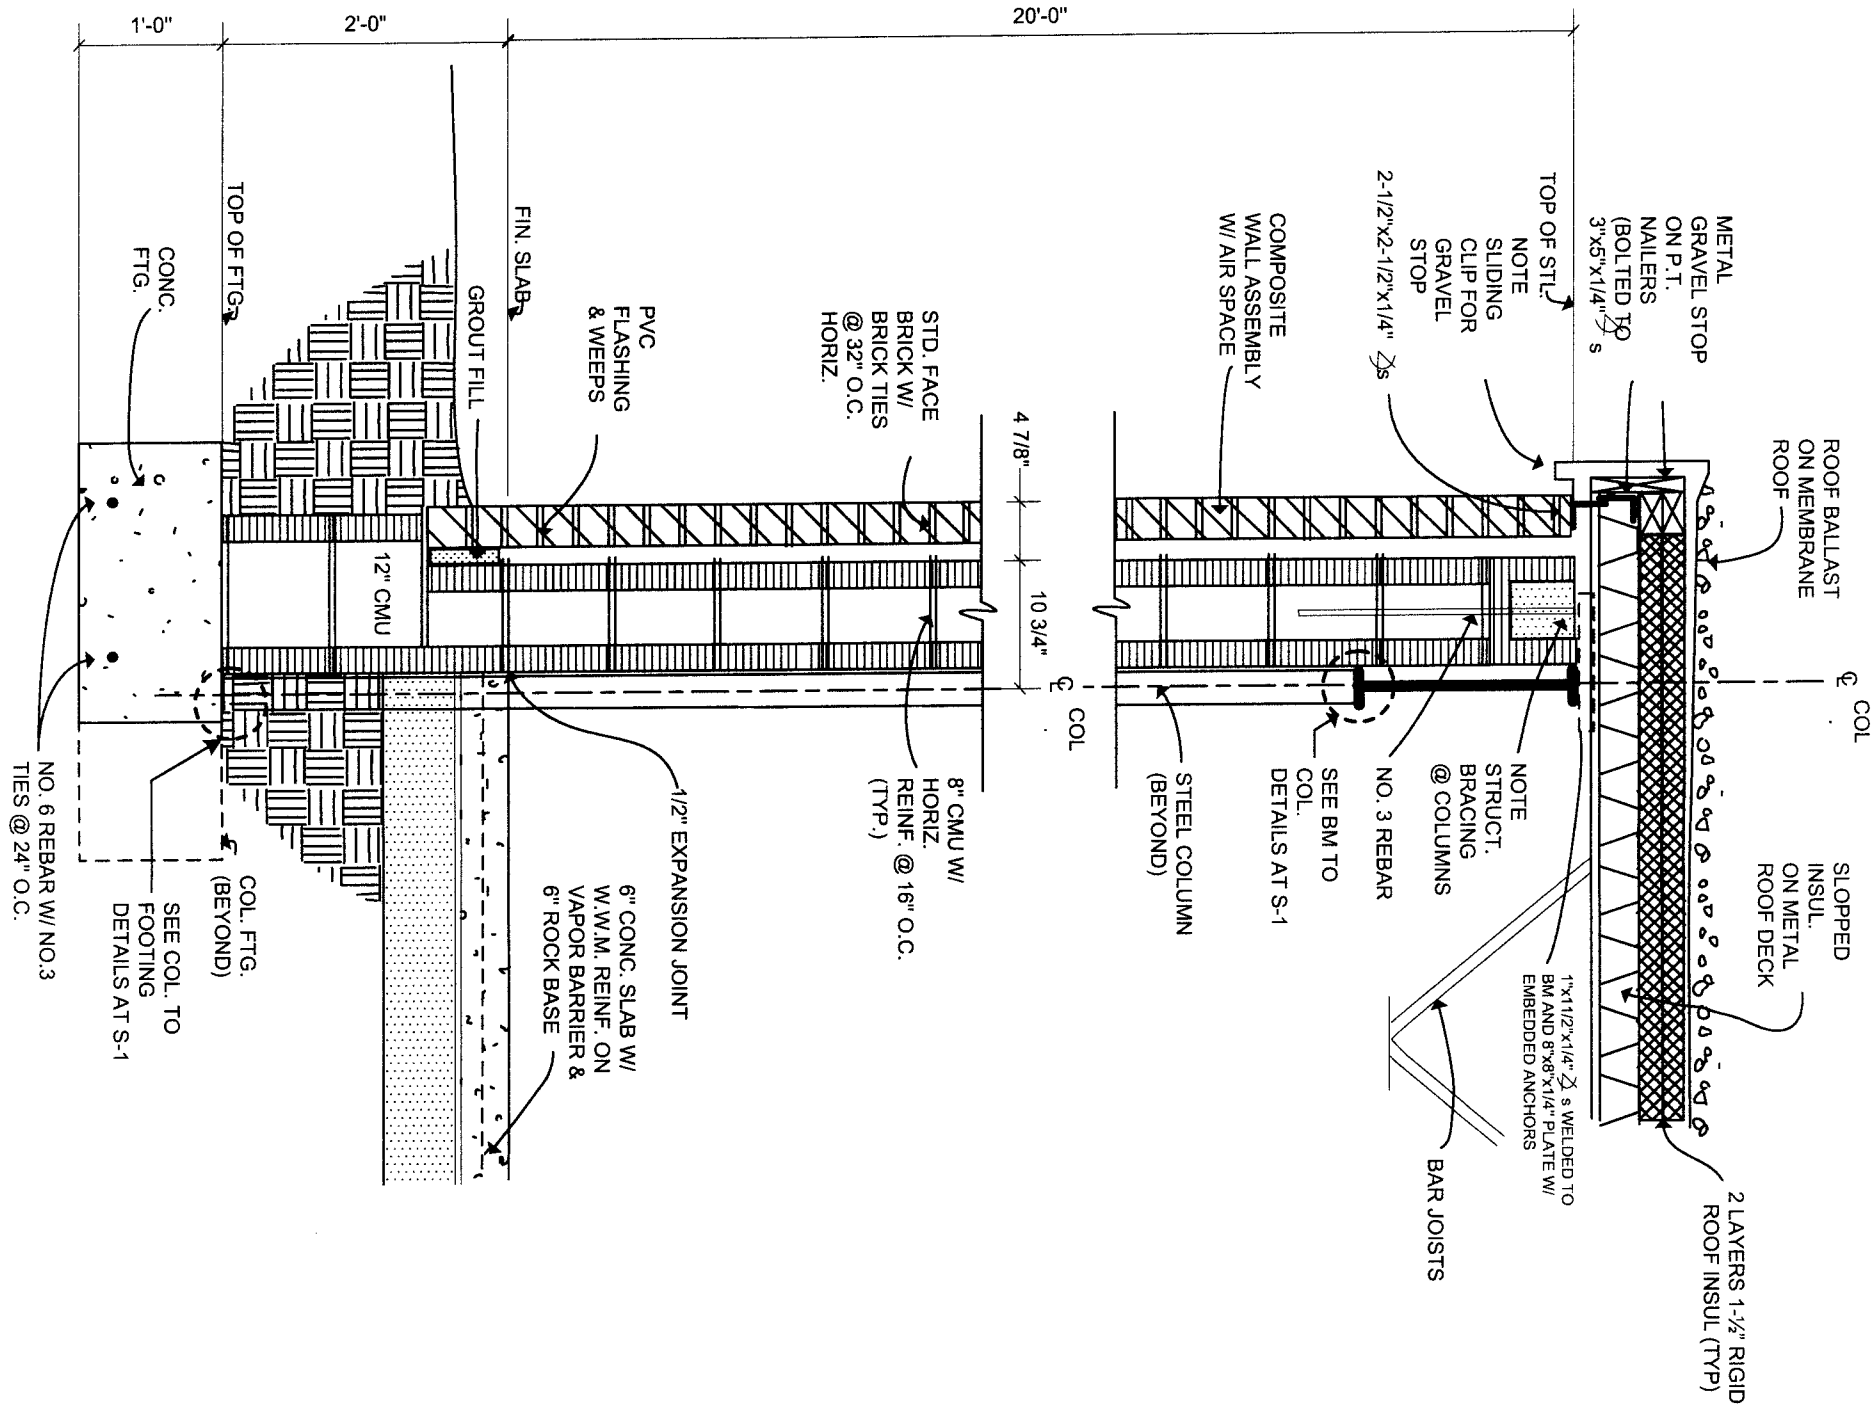


WALL SECTION
SCALE: 3/4" = 1'-0"

Scale:	3/4" = 1'	Drawn By:	
Date:	January 2010	G. P. Burdell	
STORAGE FACILITY			
WALL SECTION		Drawing Number: A-2	

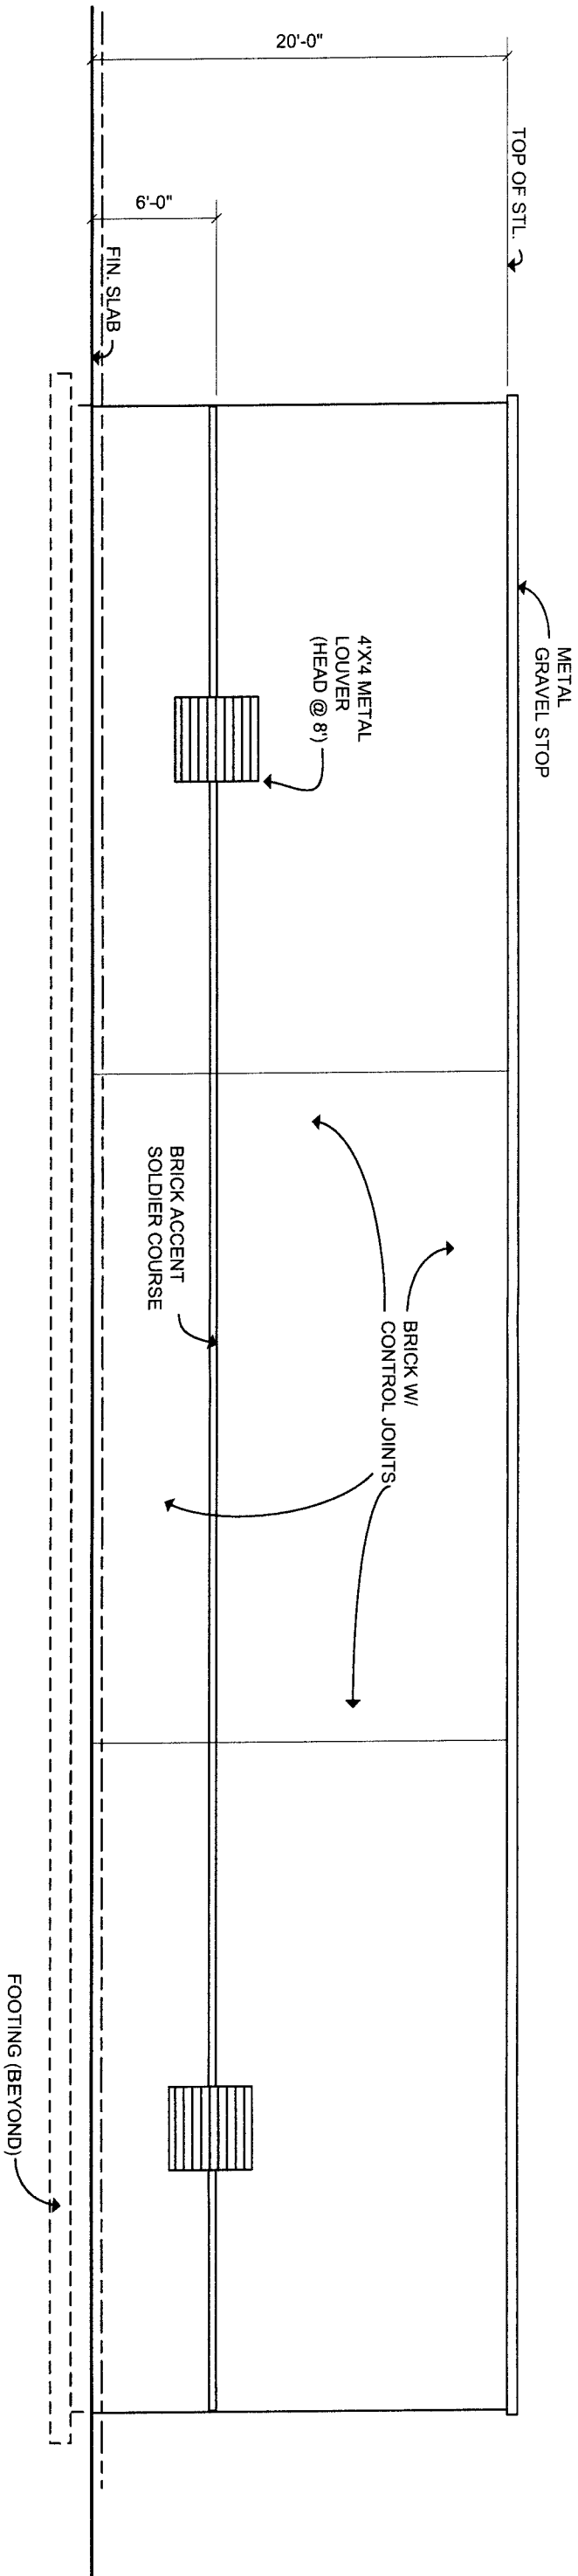


B EAST ELEVATION
SCALE: 1/8" = 1'-0"

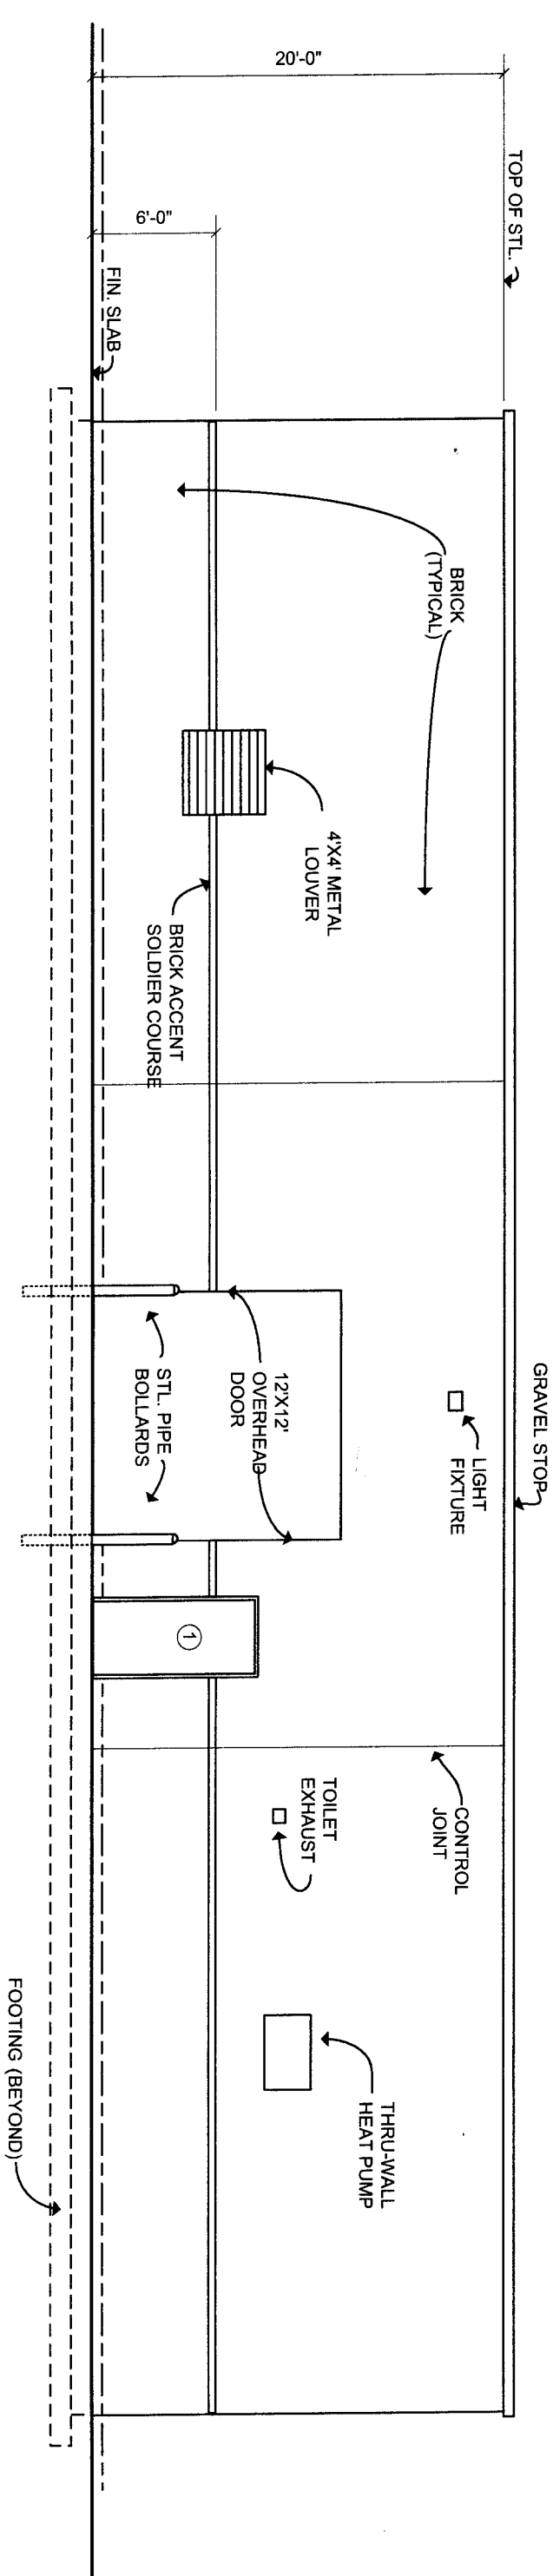


A WEST ELEVATION
SCALE: 1/8" = 1'-0"

Scale: 1/8" = 1'		Drawn By: G. P. Burdell
Date: January 2010		
STORAGE FACILITY		
ELEVATIONS		Drawing Number: A-4

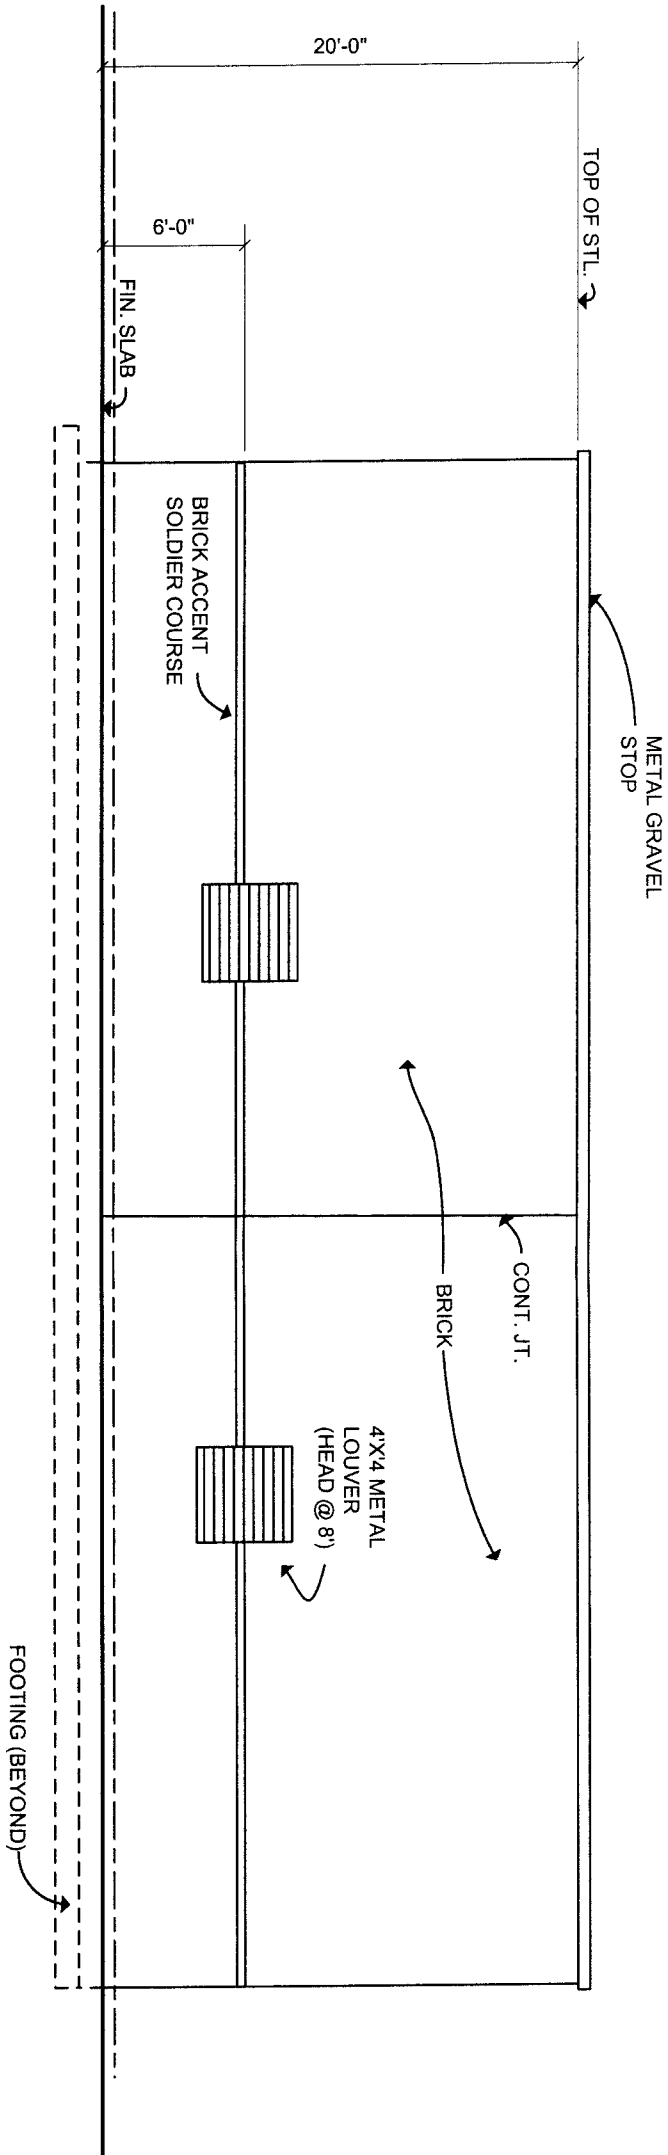


B SOUTH ELEVATION
SCALE: 1/8" = 1'-0"

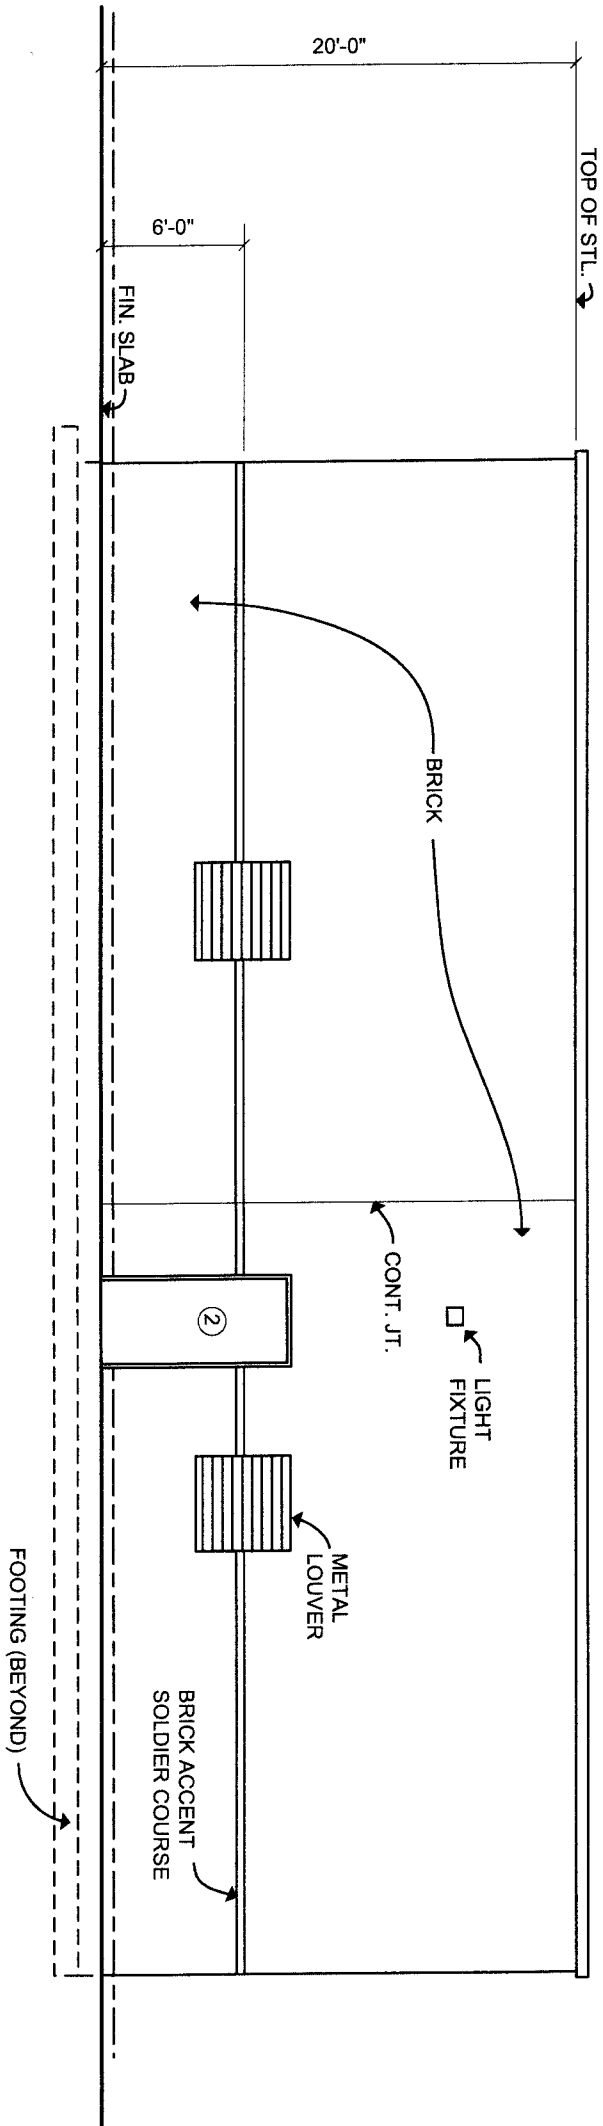

A NORTH ELEVATION
SCALE: 1/8" = 1'-0"

Scale: 1/8" = 1'		Drawn By:
Date: January 2010		G. P. Burdell
STORAGE FACILITY		
ELEVATIONS	Drawing Number: A-5	

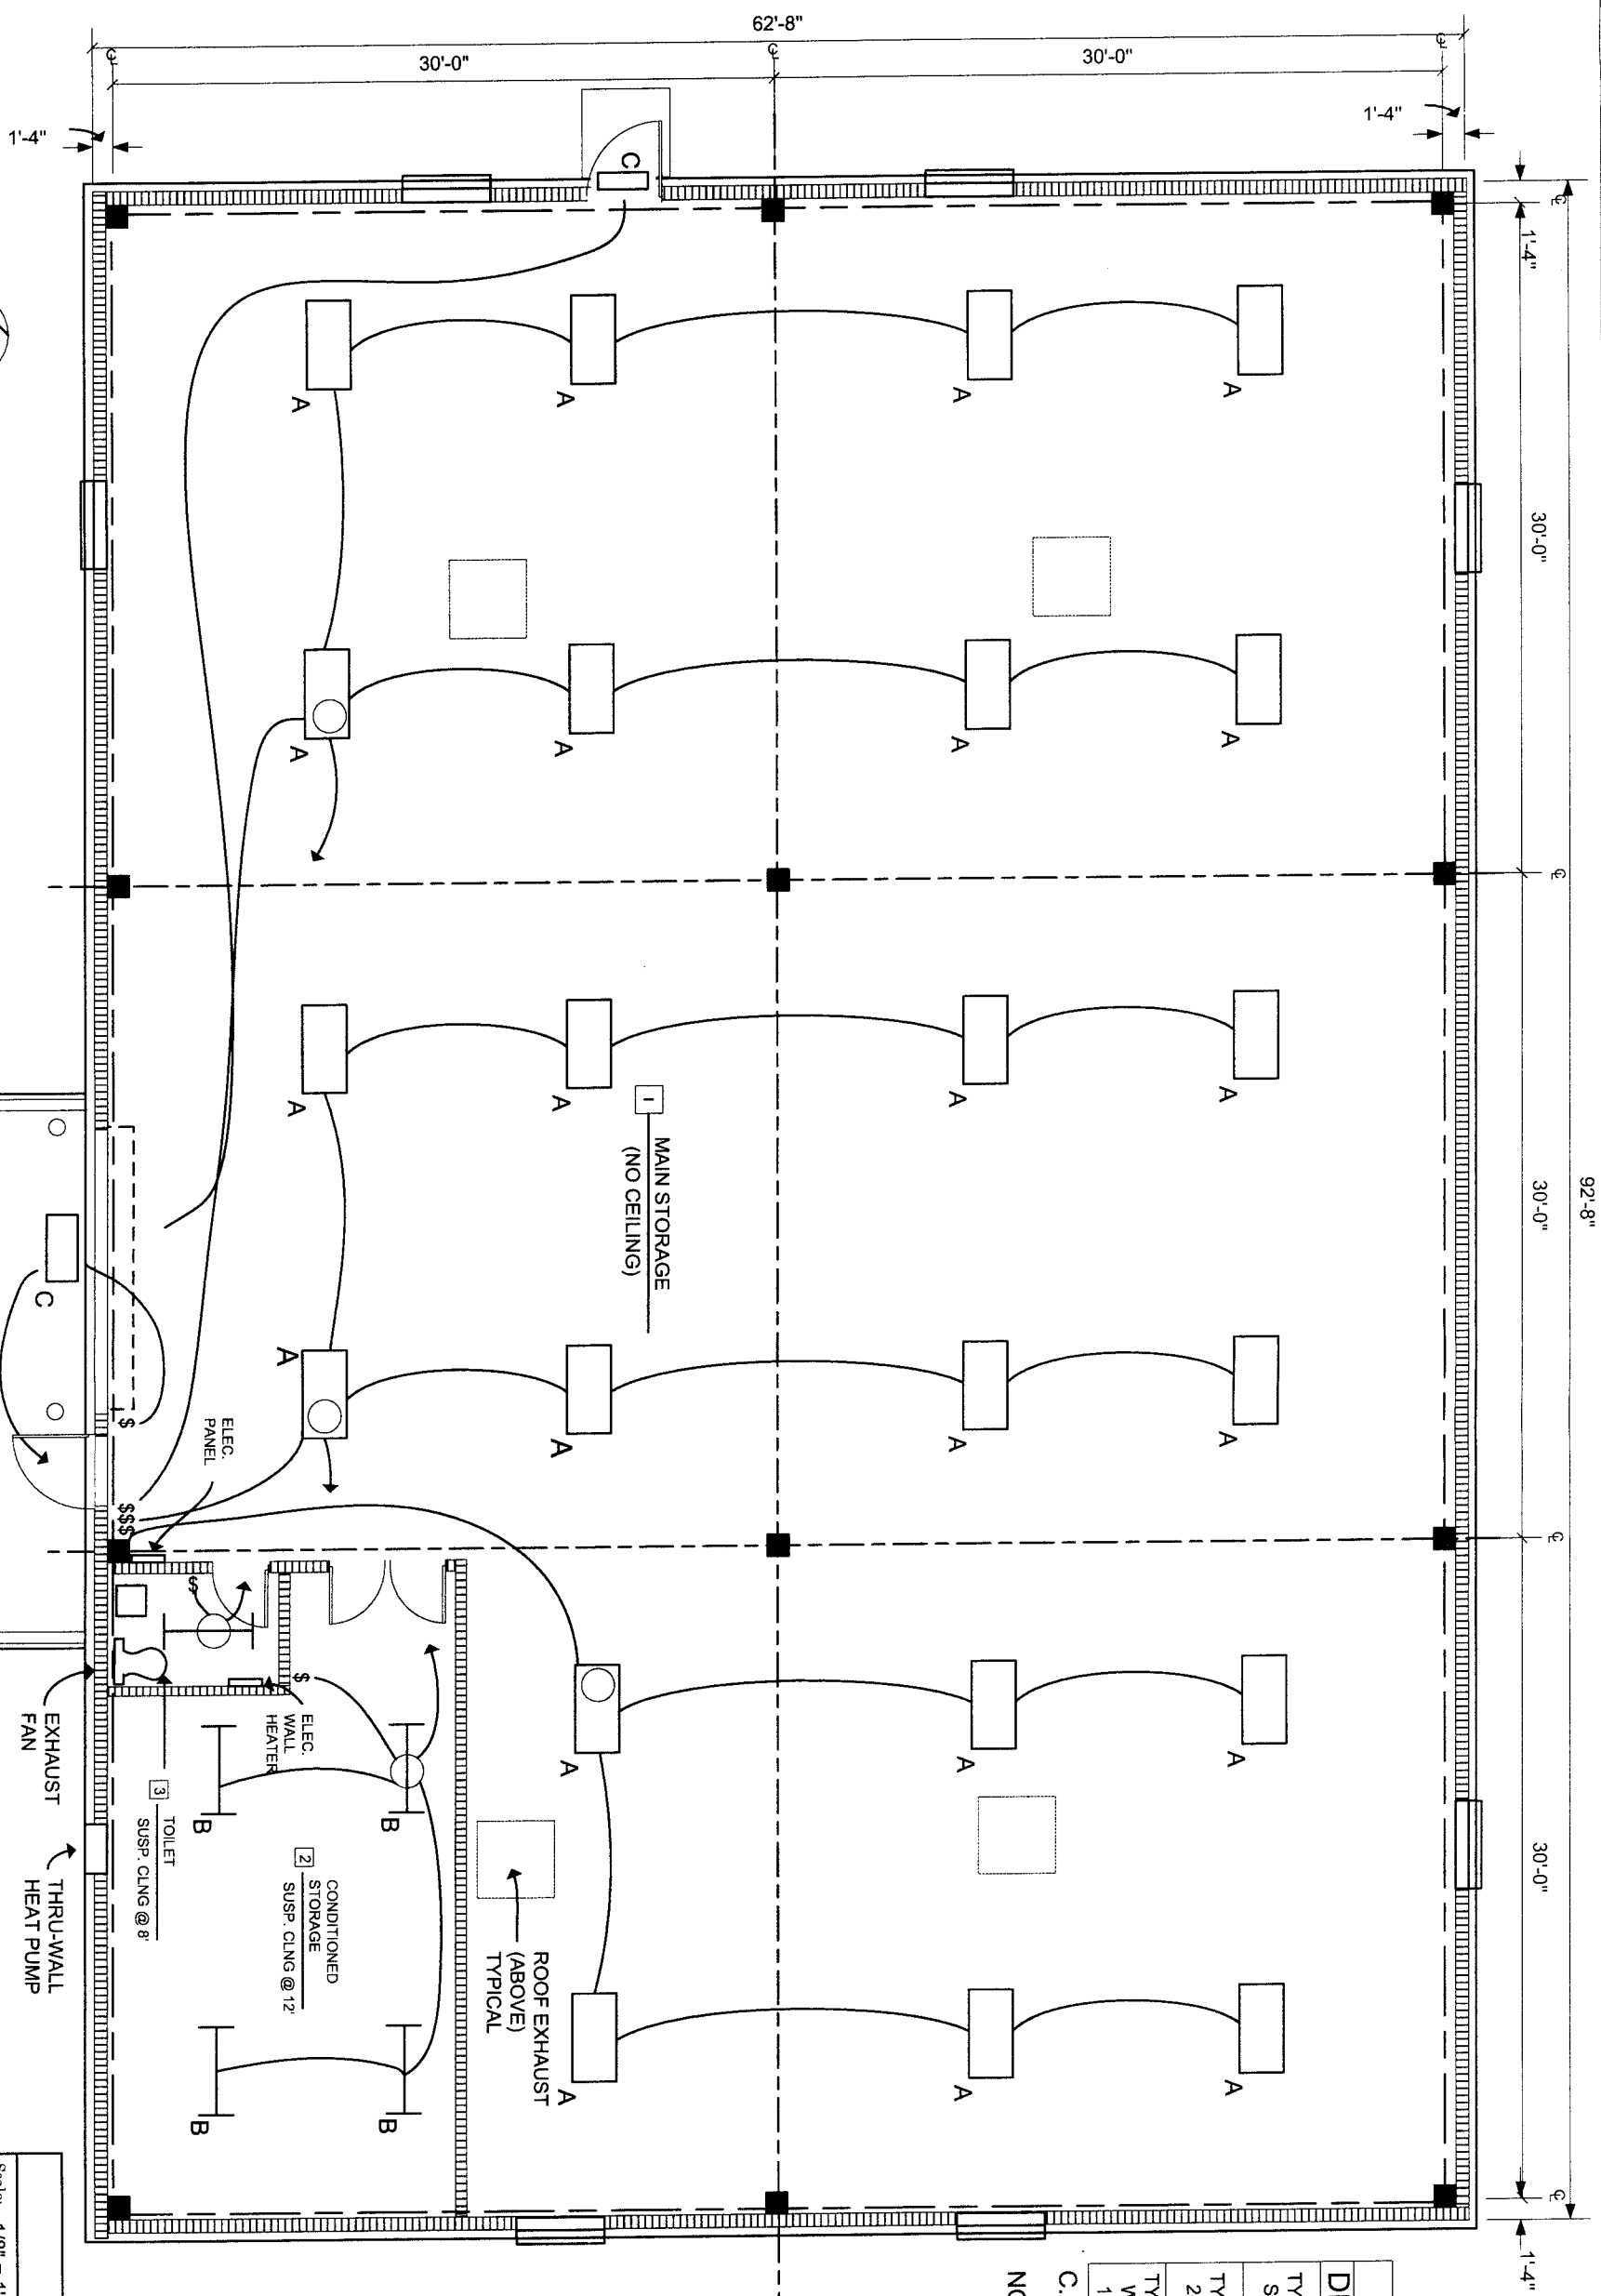

FIXTURE SCHEDULE			
DESCRIPTION	C.O.E. #	NOTES	
TYPE 'A' STD. IND. FLOUR	230A1	CHAIN HUNG FROM STL. JOISTS	
TYPE 'B' 2-LAMP STRIP	220B	CEILING MOUNTED	
TYPE 'C' WALL PACK 130W HPS	501C	WALL MOUNTED 16 A.F.F.	

C.O.E. # PER STD DWG 40-06-04


NOTE: FIXTURE SYMBOLS NOT
DRAWN TO SCALE

		Scale: 1/8" = 1'
		Drawn By: G. P. Burdell
Date: January 2010		


STORAGE FACILITY

LIGHTING PLAN

 Drawing Number:
E-1





A LIGHTING PLAN
SCALE: 1/8" = 1'-0"

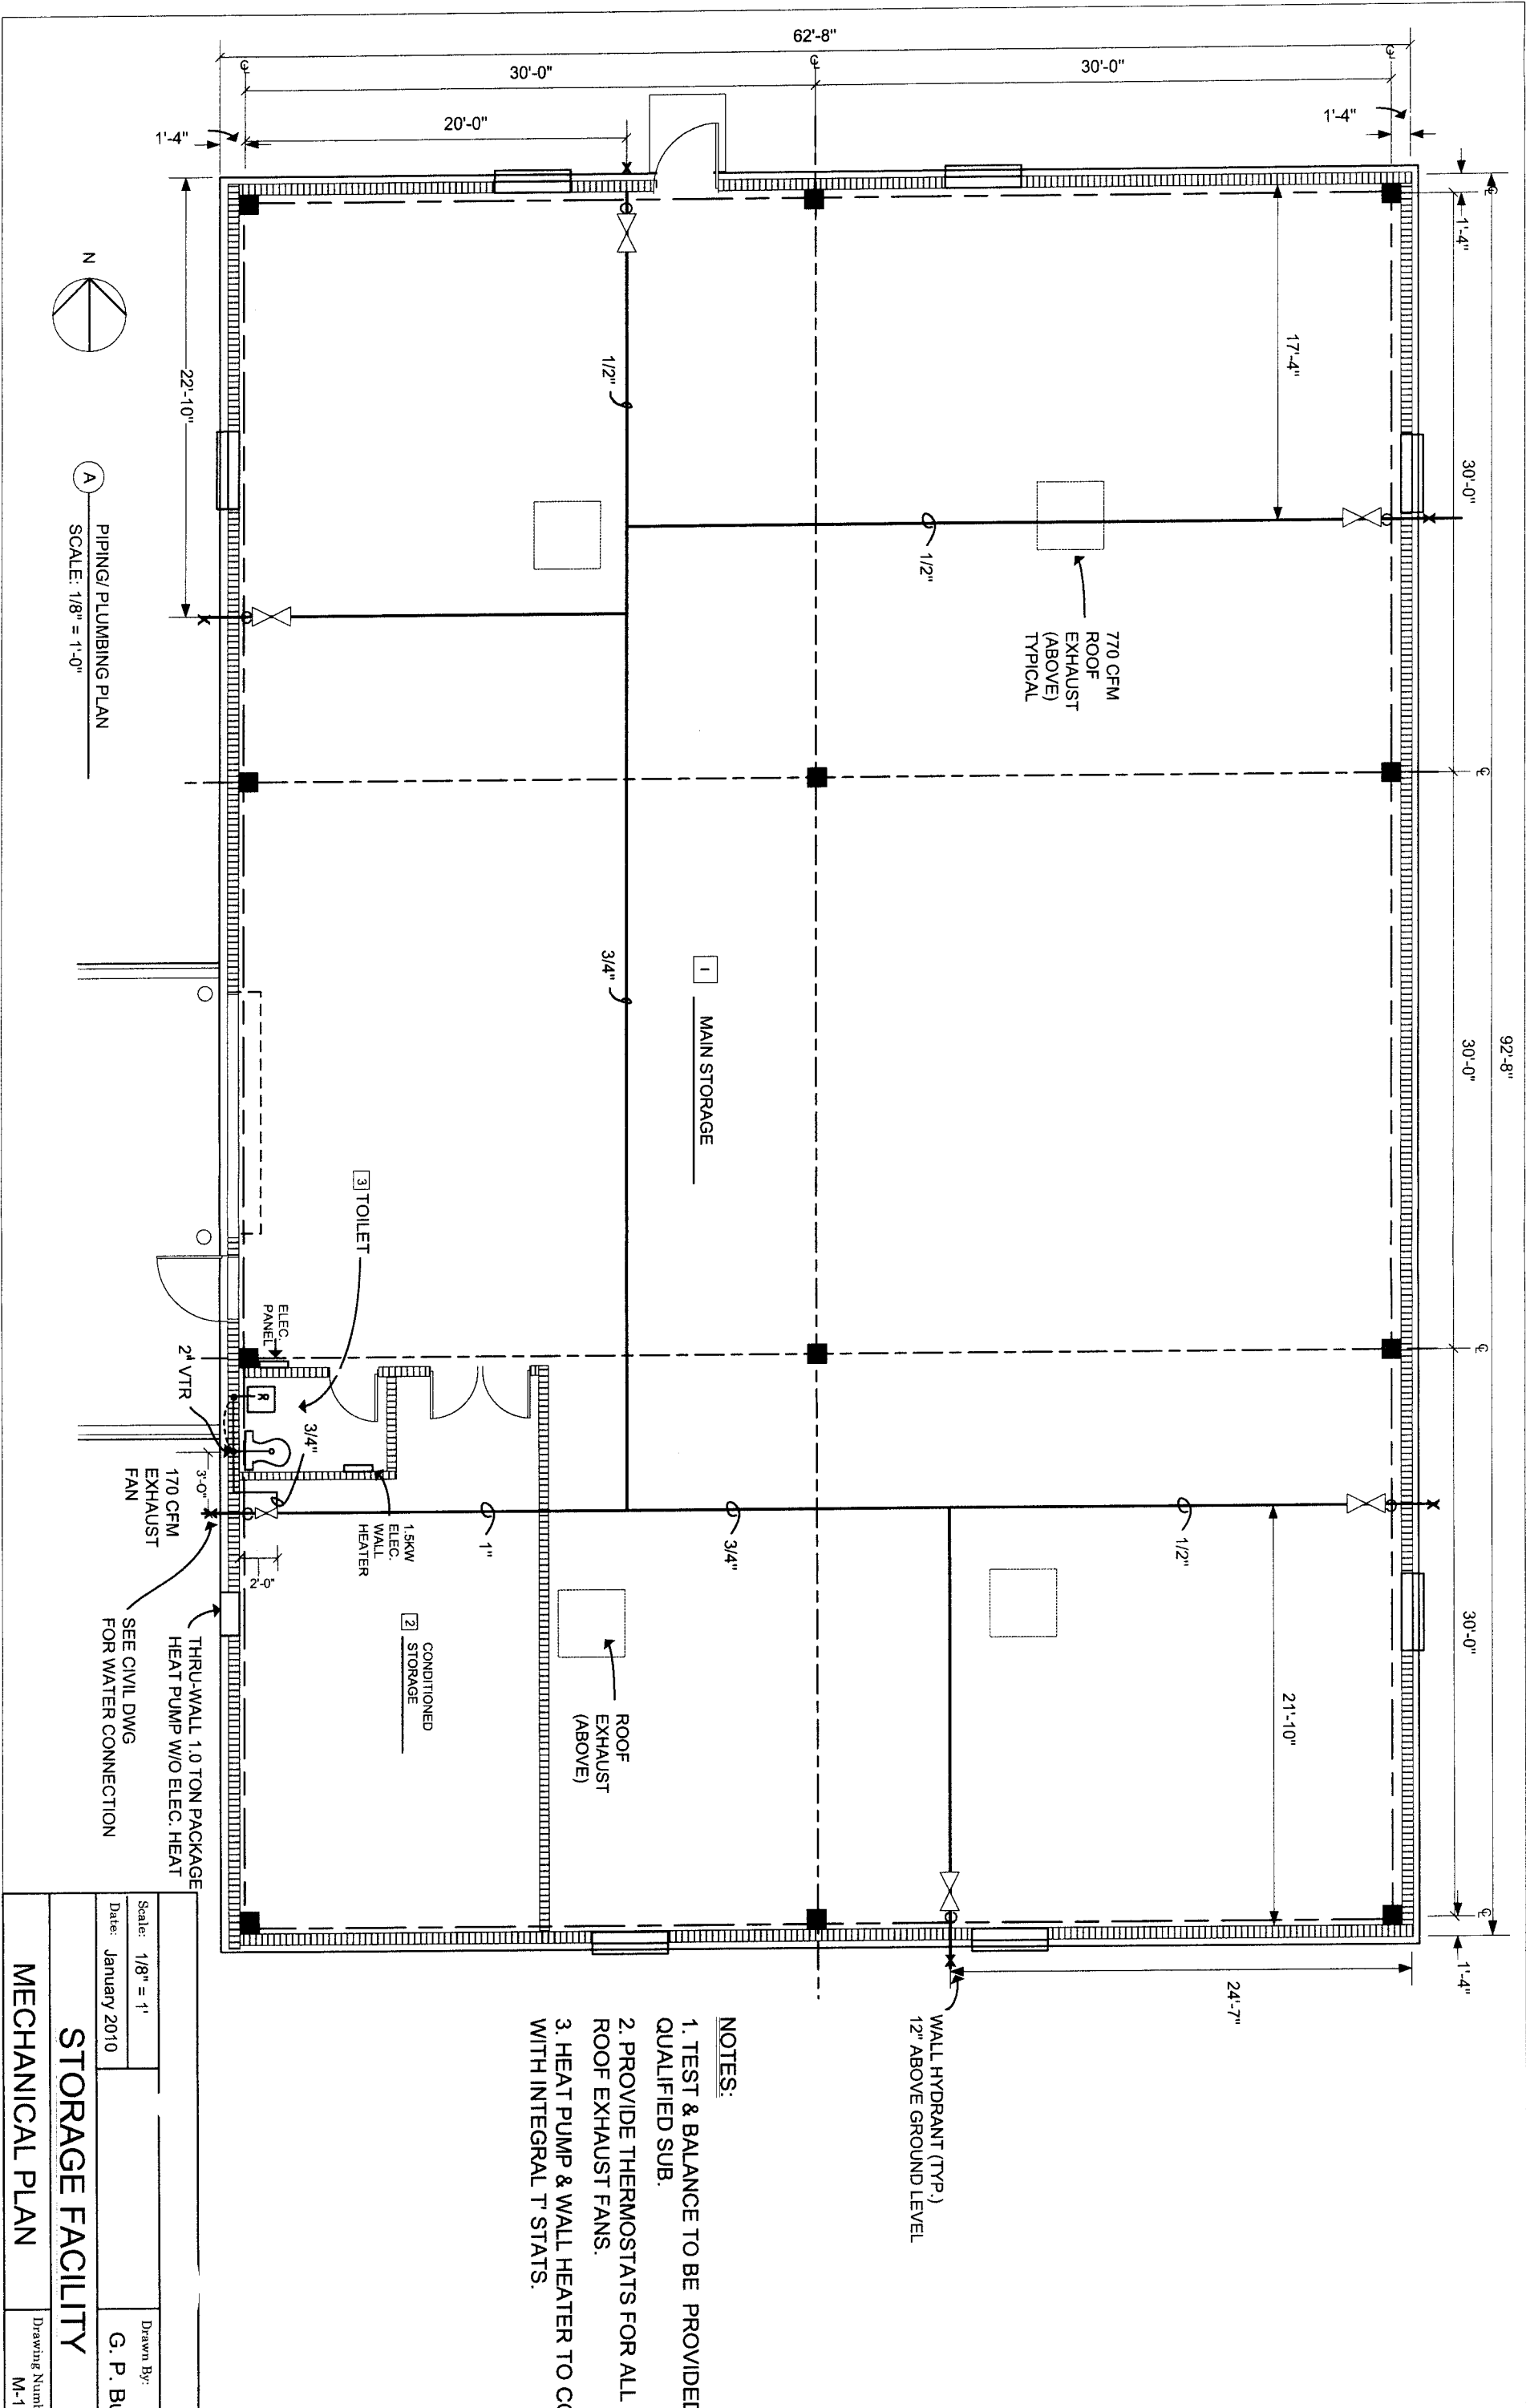



Scale: 1/8" = 1'		Drawn By:	
Date: January 2010		G. P. Burdell	
MECHANICAL PLAN		Drawing Number:	
M-1		M-1	

FIXTURE SCHEDULE	
NO	DESCRIPTION
P-1	FLR. MTD. WATER CLOSET
P-2	WALL HUNG LAVATORY
WH-1	1.5 KW UNDER COUNTER WATER HEATER

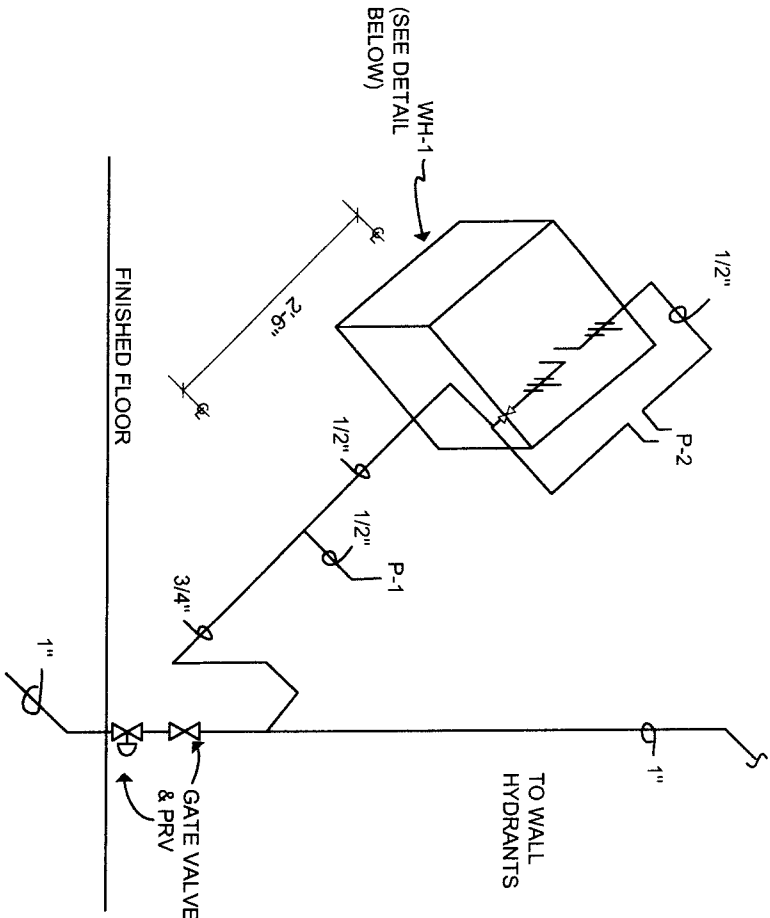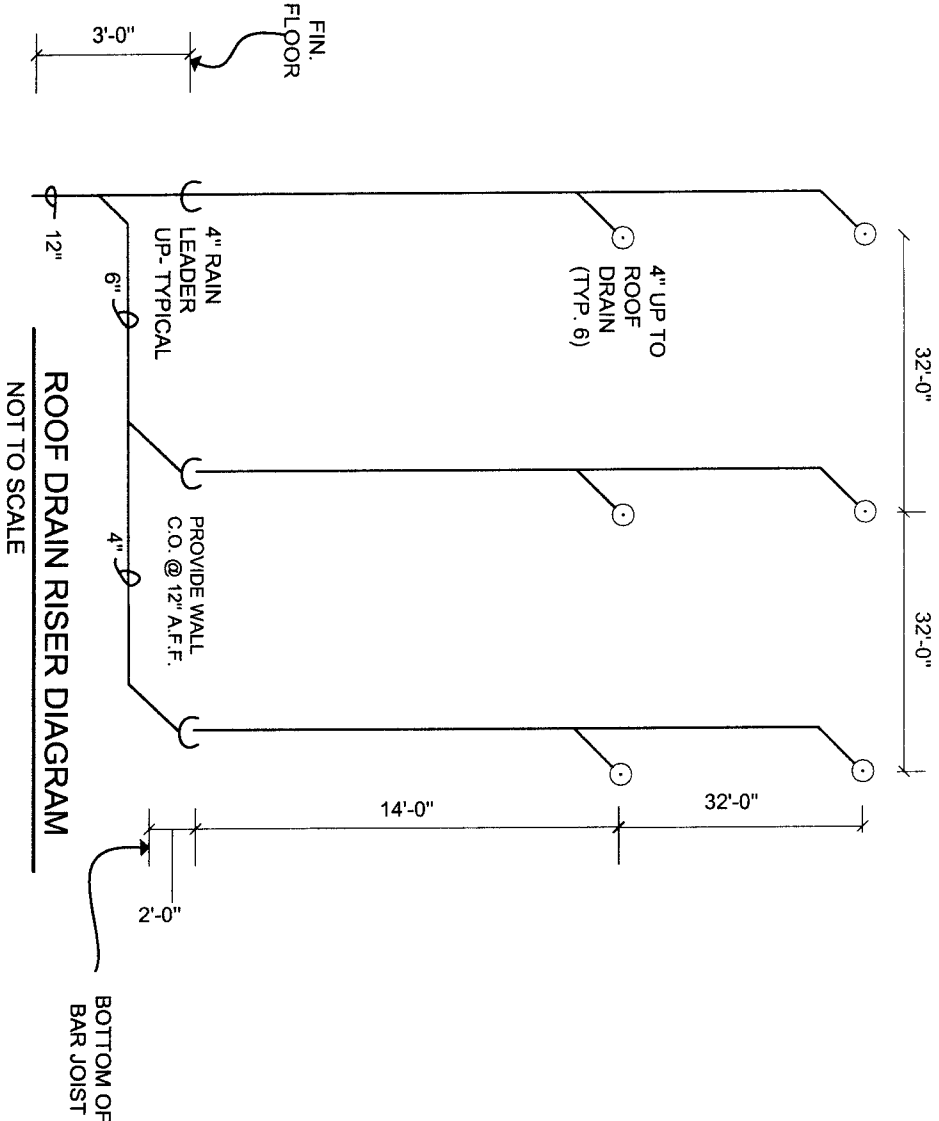

NOTES:

1. USE TYPE 'K' COPPER BELOW GROUND AND TYPE 'L' ABOVE GROUND.
2. RUN COPPER TUBING/PIPING AS HIGH AS POSSIBLE.
3. USE CAST IRON H&S BELOW GROUND WASTE PIPING AND NO HUB ABOVE GROUND.
4. USE 1" FIBERGLASS INSULATION ON HORIZONTAL AND VERTICAL PIPE TO ROOF DRAINS AND ON DOMESTIC WATER LINES.

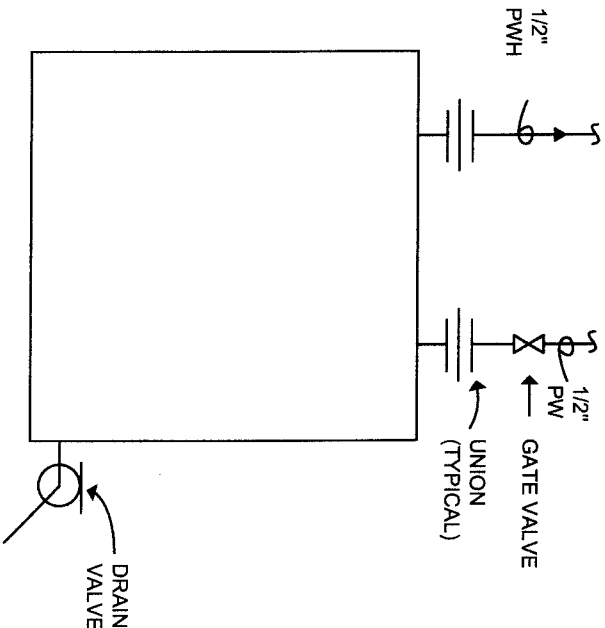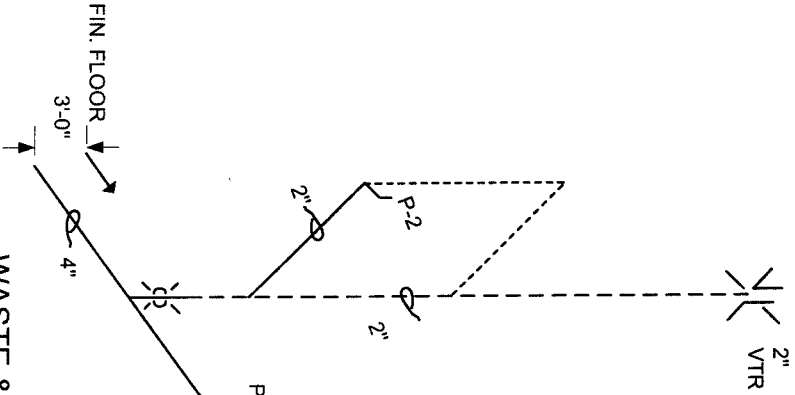

Scale: N/A		Drawn By: G. P. Burdell
Date: January 2010		
STORAGE FACILITY		
MECHANICAL DETAILS		Drawing Number: M-2